


LEGEND
 SOLID LINES REPRESENT A PIPING CONNECTIONS
 DASHED LINES REPRESENT ELECTRICAL CONNECTIONS

1	NPT OUTLET
2	FNPT ISOLATION BALL VALVE
3	FNPT CHECK VALVE
4	NIPPLE
5	FNPT ISOLATION BALL VALVE
6	MNPT 90-DEG ELBOW
7	FNPT UNION

<table border="1"> <tr> <th>No</th> <th>DATE</th> <th>NAME</th> <th>REVISION</th> </tr> <tr> <td>01</td> <td></td> <td></td> <td></td> </tr> <tr> <td>02</td> <td></td> <td></td> <td></td> </tr> <tr> <td>03</td> <td></td> <td></td> <td></td> </tr> <tr> <td>04</td> <td></td> <td></td> <td></td> </tr> <tr> <td>05</td> <td></td> <td></td> <td></td> </tr> </table>	No	DATE	NAME	REVISION	01				02				03				04				05				<table border="1"> <tr> <th>NAME</th> <th>DATE</th> </tr> <tr> <td>DRAWN</td> <td>2/16/15</td> </tr> <tr> <td>CHECKED</td> <td>-</td> </tr> <tr> <td>ENGINEER</td> <td>-</td> </tr> </table>	NAME	DATE	DRAWN	2/16/15	CHECKED	-	ENGINEER	-	<p>PROPRIETARY AND CONFIDENTIAL THE INFORMATION CONTAINED IN THIS DRAWING IS THE SOLE PROPERTY OF ENVIROMIX. ANY REPRODUCTION IN PART OR AS A WHOLE WITHOUT THE WRITTEN PERMISSION OF ENVIROMIX IS PROHIBITED.</p>	<table border="1"> <tr> <th>MATERIAL</th> <th>QUANTITY</th> </tr> <tr> <td>-</td> <td>-</td> </tr> <tr> <td>-</td> <td>-</td> </tr> </table>	MATERIAL	QUANTITY	-	-	-	-	<p>PROJECT: STANDARD DRAWINGS COMPLETE SET</p>		<p>COMMENTS: -</p>	<p>ITEM AQUABLEND P&ID</p>	<p>SCALE: 1:1</p>	<p>DWG No.: --P&ID-1</p>	<p>2/18/2015</p>	<p>REV 1.0</p>	<p>SHEET: 1 OF 2</p>
	No	DATE	NAME	REVISION																																														
	01																																																	
	02																																																	
	03																																																	
04																																																		
05																																																		
NAME	DATE																																																	
DRAWN	2/16/15																																																	
CHECKED	-																																																	
ENGINEER	-																																																	
MATERIAL	QUANTITY																																																	
-	-																																																	
-	-																																																	

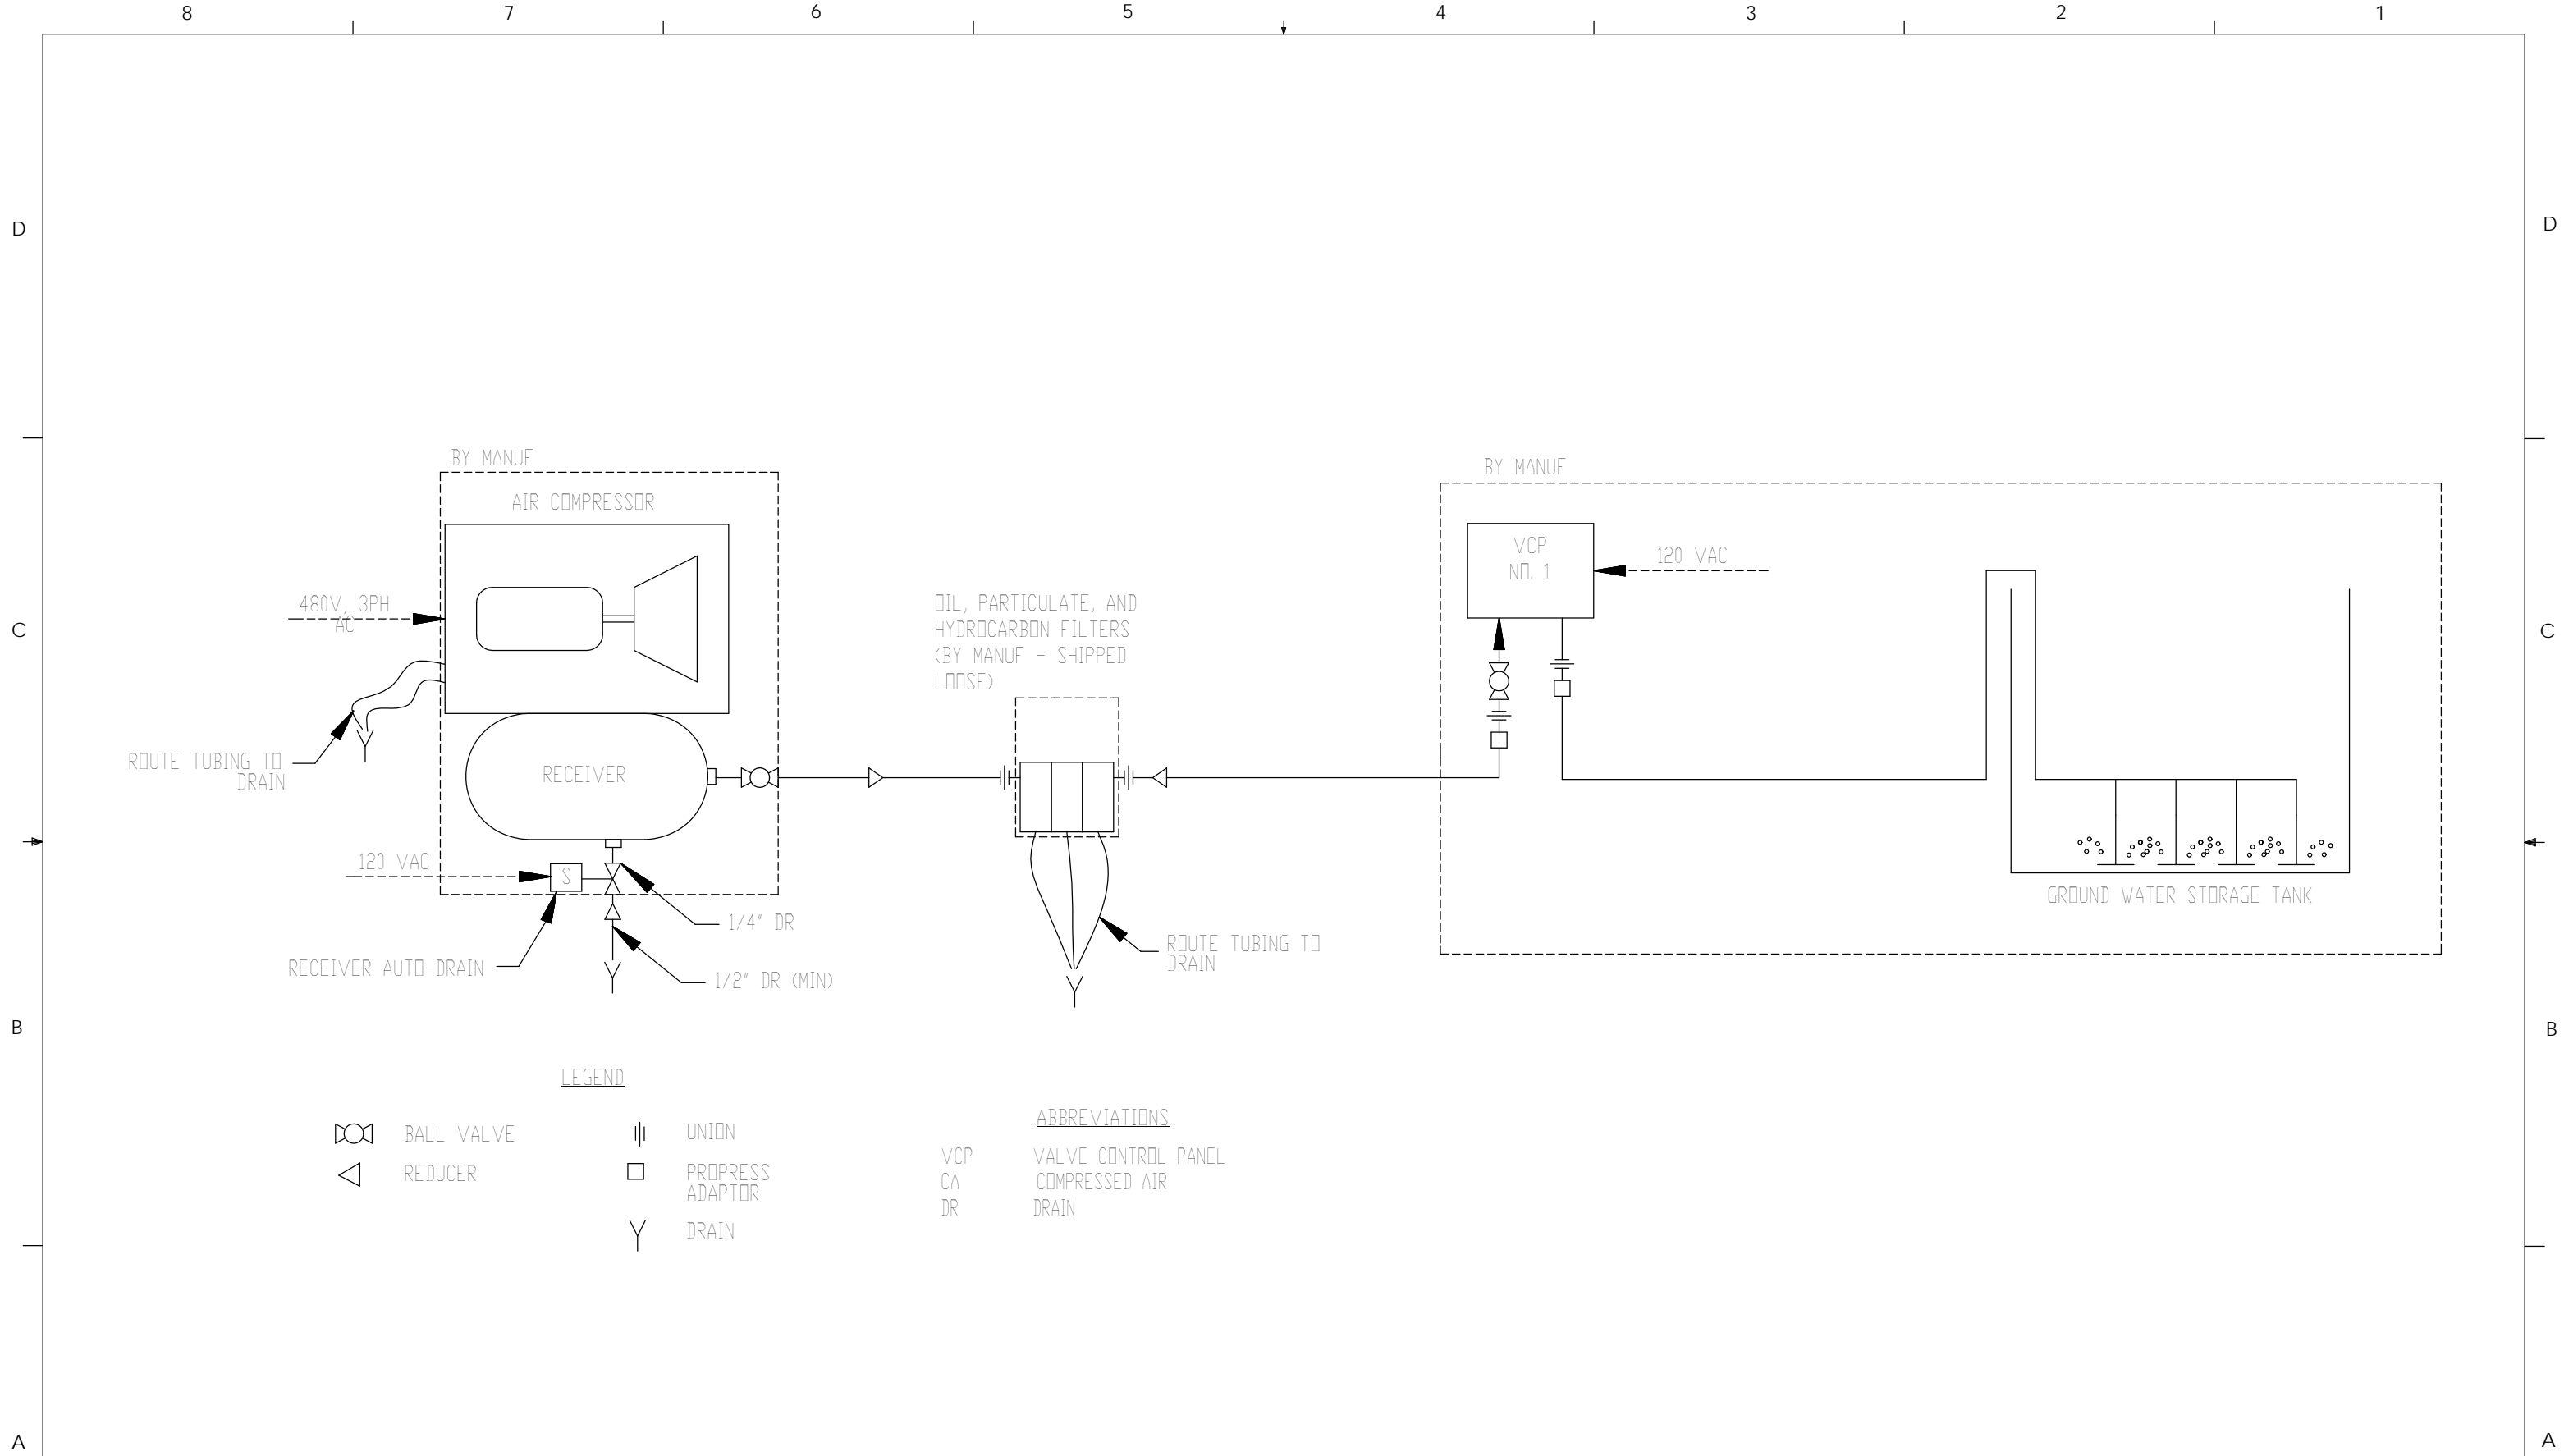

NO	DATE	NAME	REVISION	NAME	DATE
01					
02				DRAWN	WLE 2/16/15
03				CHECKED	-
04				ENGINEER	-
05					

PROPRIETARY AND CONFIDENTIAL
 THE INFORMATION CONTAINED IN THIS DRAWING IS THE SOLE PROPERTY OF ENVIROMIX. ANY REPRODUCTION IN PART OR AS A WHOLE WITHOUT THE WRITTEN PERMISSION OF ENVIROMIX IS PROHIBITED.

MATERIAL	QUANTITY
-	-
-	-

PROJECT:
 STANDARD DRAWINGS COMPLETE SET



COMMENTS:
 -

ITEM
 AQUABLEND P&ID

SCALE: 1:1

REV
2/18/2015
1.0
P&ID - 2 OF 2