

No	DATE	NAME	REVISION	NAME	DATE
01					
02				DRAWN	WLE 2/16/15
03				CHECKED	
04				ENGINEER	
05					

PROPRIETARY AND CONFIDENTIAL
 THE INFORMATION CONTAINED IN THIS DRAWING IS THE SOLE PROPERTY OF ENVIROMIX. ANY REPRODUCTION IN PART OR AS A WHOLE WITHOUT THE WRITTEN PERMISSION OF ENVIROMIX IS PROHIBITED.

MATERIAL	PROJECT:
	STANDARD DRAWINGS COMPLETE SET
QUANTITY	




COMMENTS:

ITEM BIOMIX P&ID
 SCALE: 1:1 DWG No.: 60xx-P&ID-1

REV 1.0
 2/18/2015
 SHEET: 1 OF 2

8 7 6 5 4 3 2 1

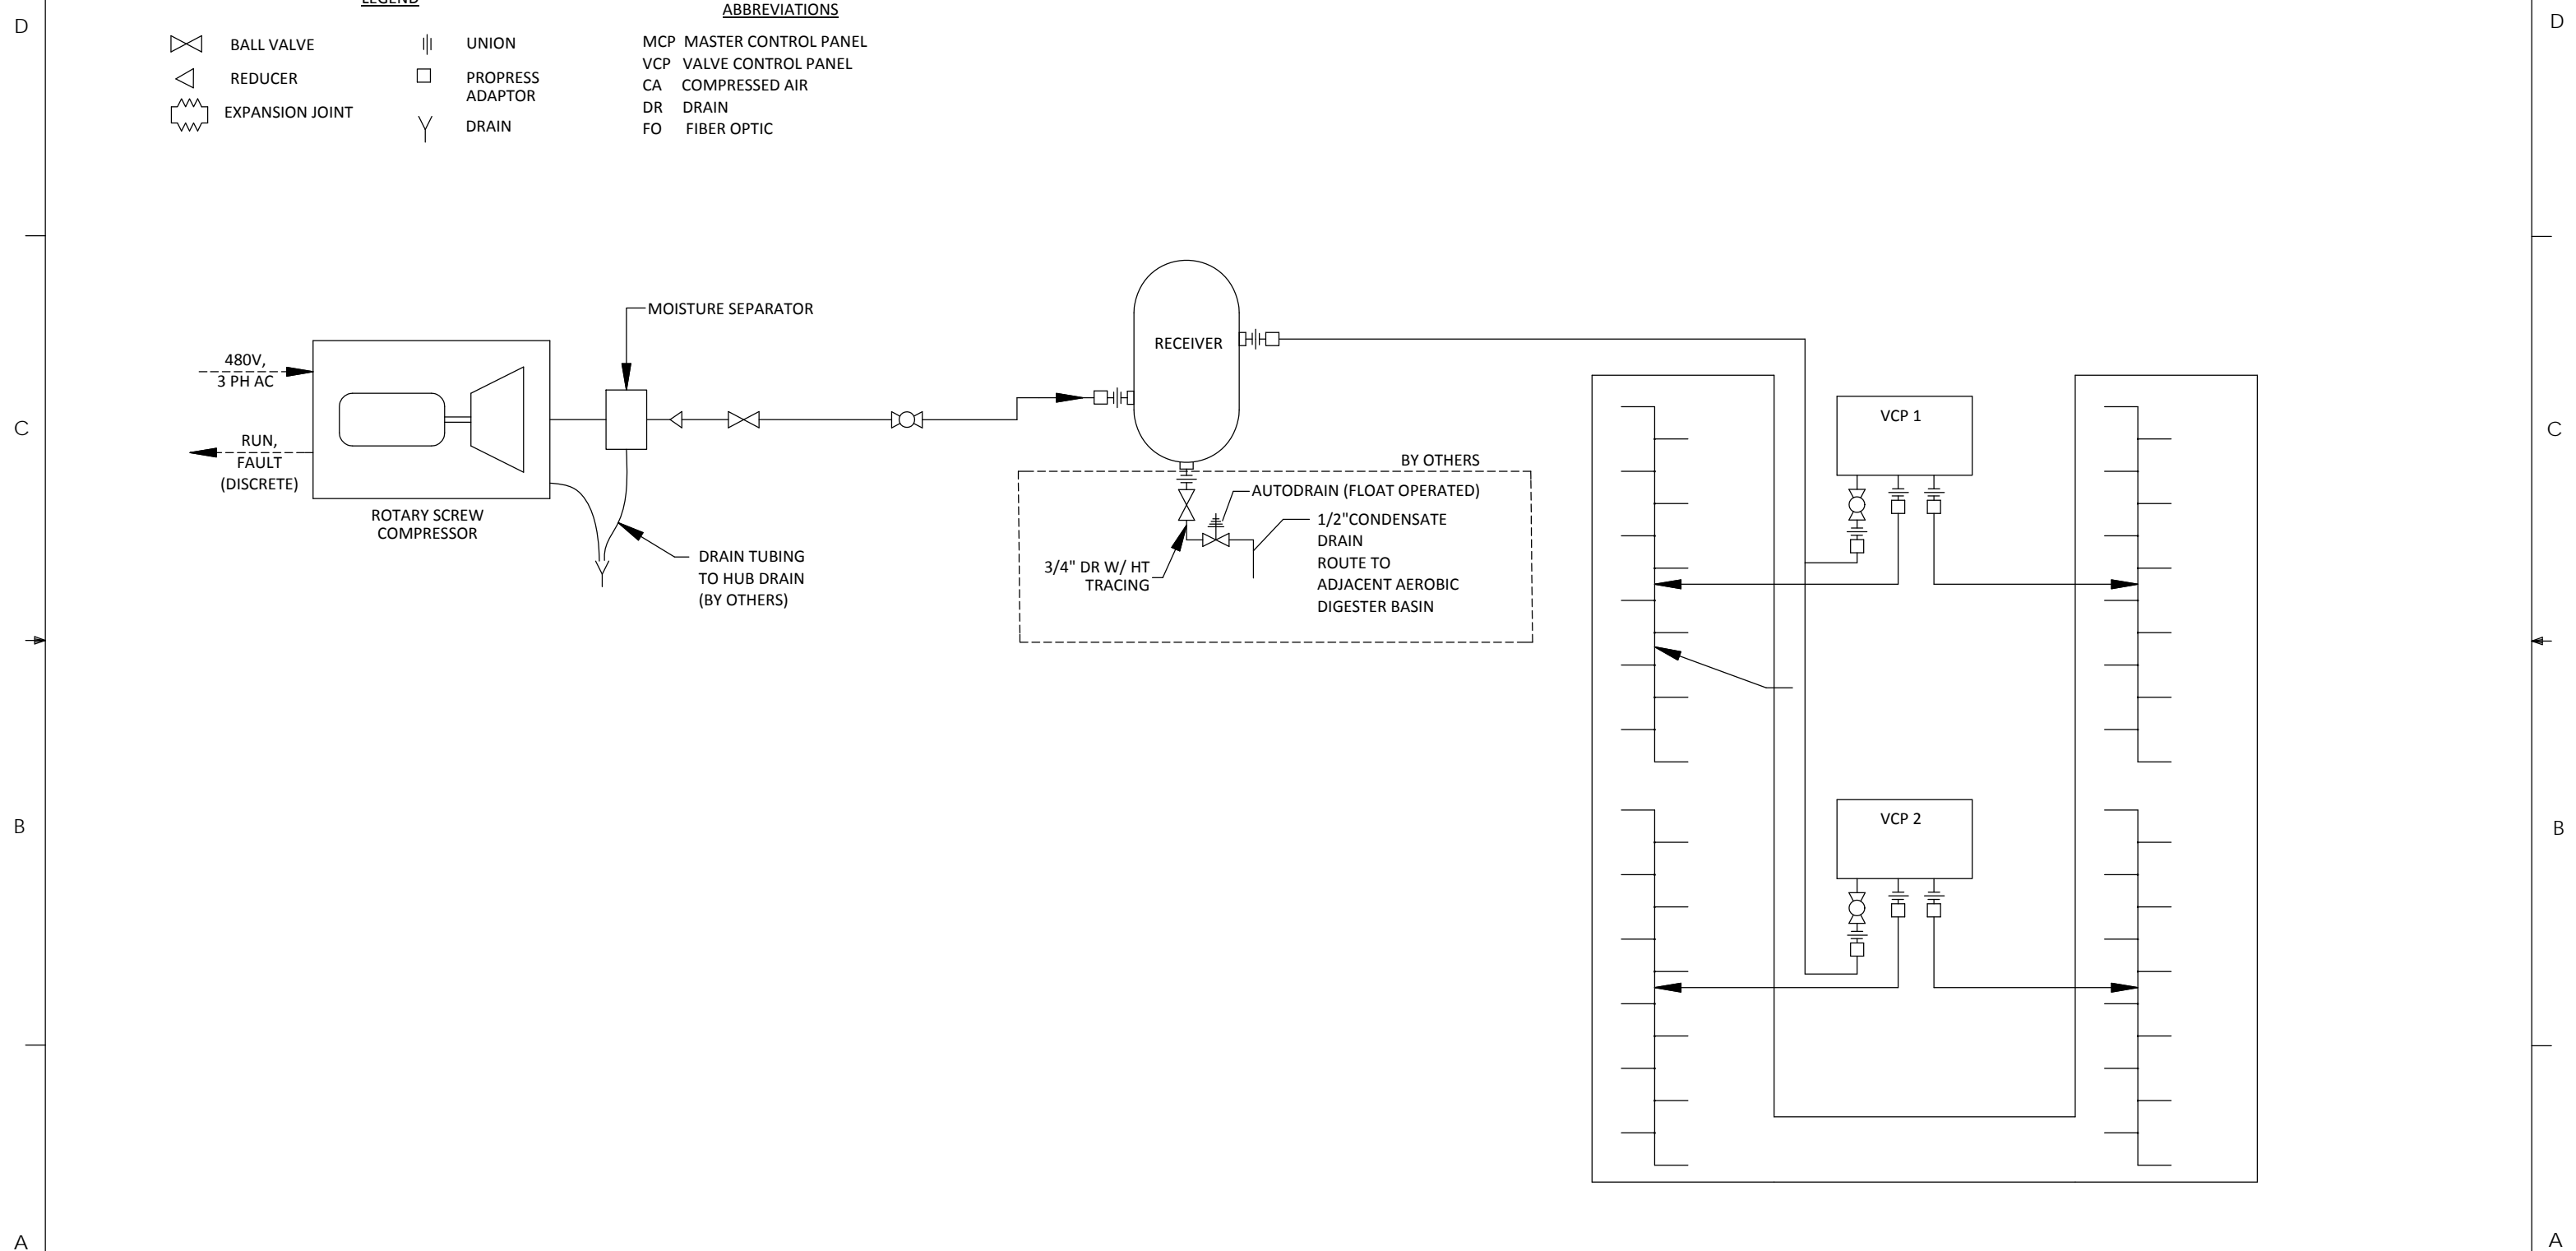

No	DATE	NAME	REVISION	NAME	DATE
01					
02				DRAWN	WLE 2/16/15
03				CHECKED	
04				ENGINEER	
05					

PROPRIETARY AND CONFIDENTIAL
 THE INFORMATION CONTAINED IN THIS DRAWING IS THE SOLE PROPERTY OF ENVIROMIX. ANY REPRODUCTION IN PART OR AS A WHOLE WITHOUT THE WRITTEN PERMISSION OF ENVIROMIX IS PROHIBITED.

MATERIAL	PROJECT:
QUANTITY	STANDARD DRAWINGS COMPLETE SET



COMMENTS:

ITEM
 BIOMIX P&ID HARD
 PIPED
 SCALE: 1:1 60xx

2/18/2015
REV 1.0
 P&ID - 2 OF 2

8 7 6 5 4 3 2 1